


Doc# 2302133

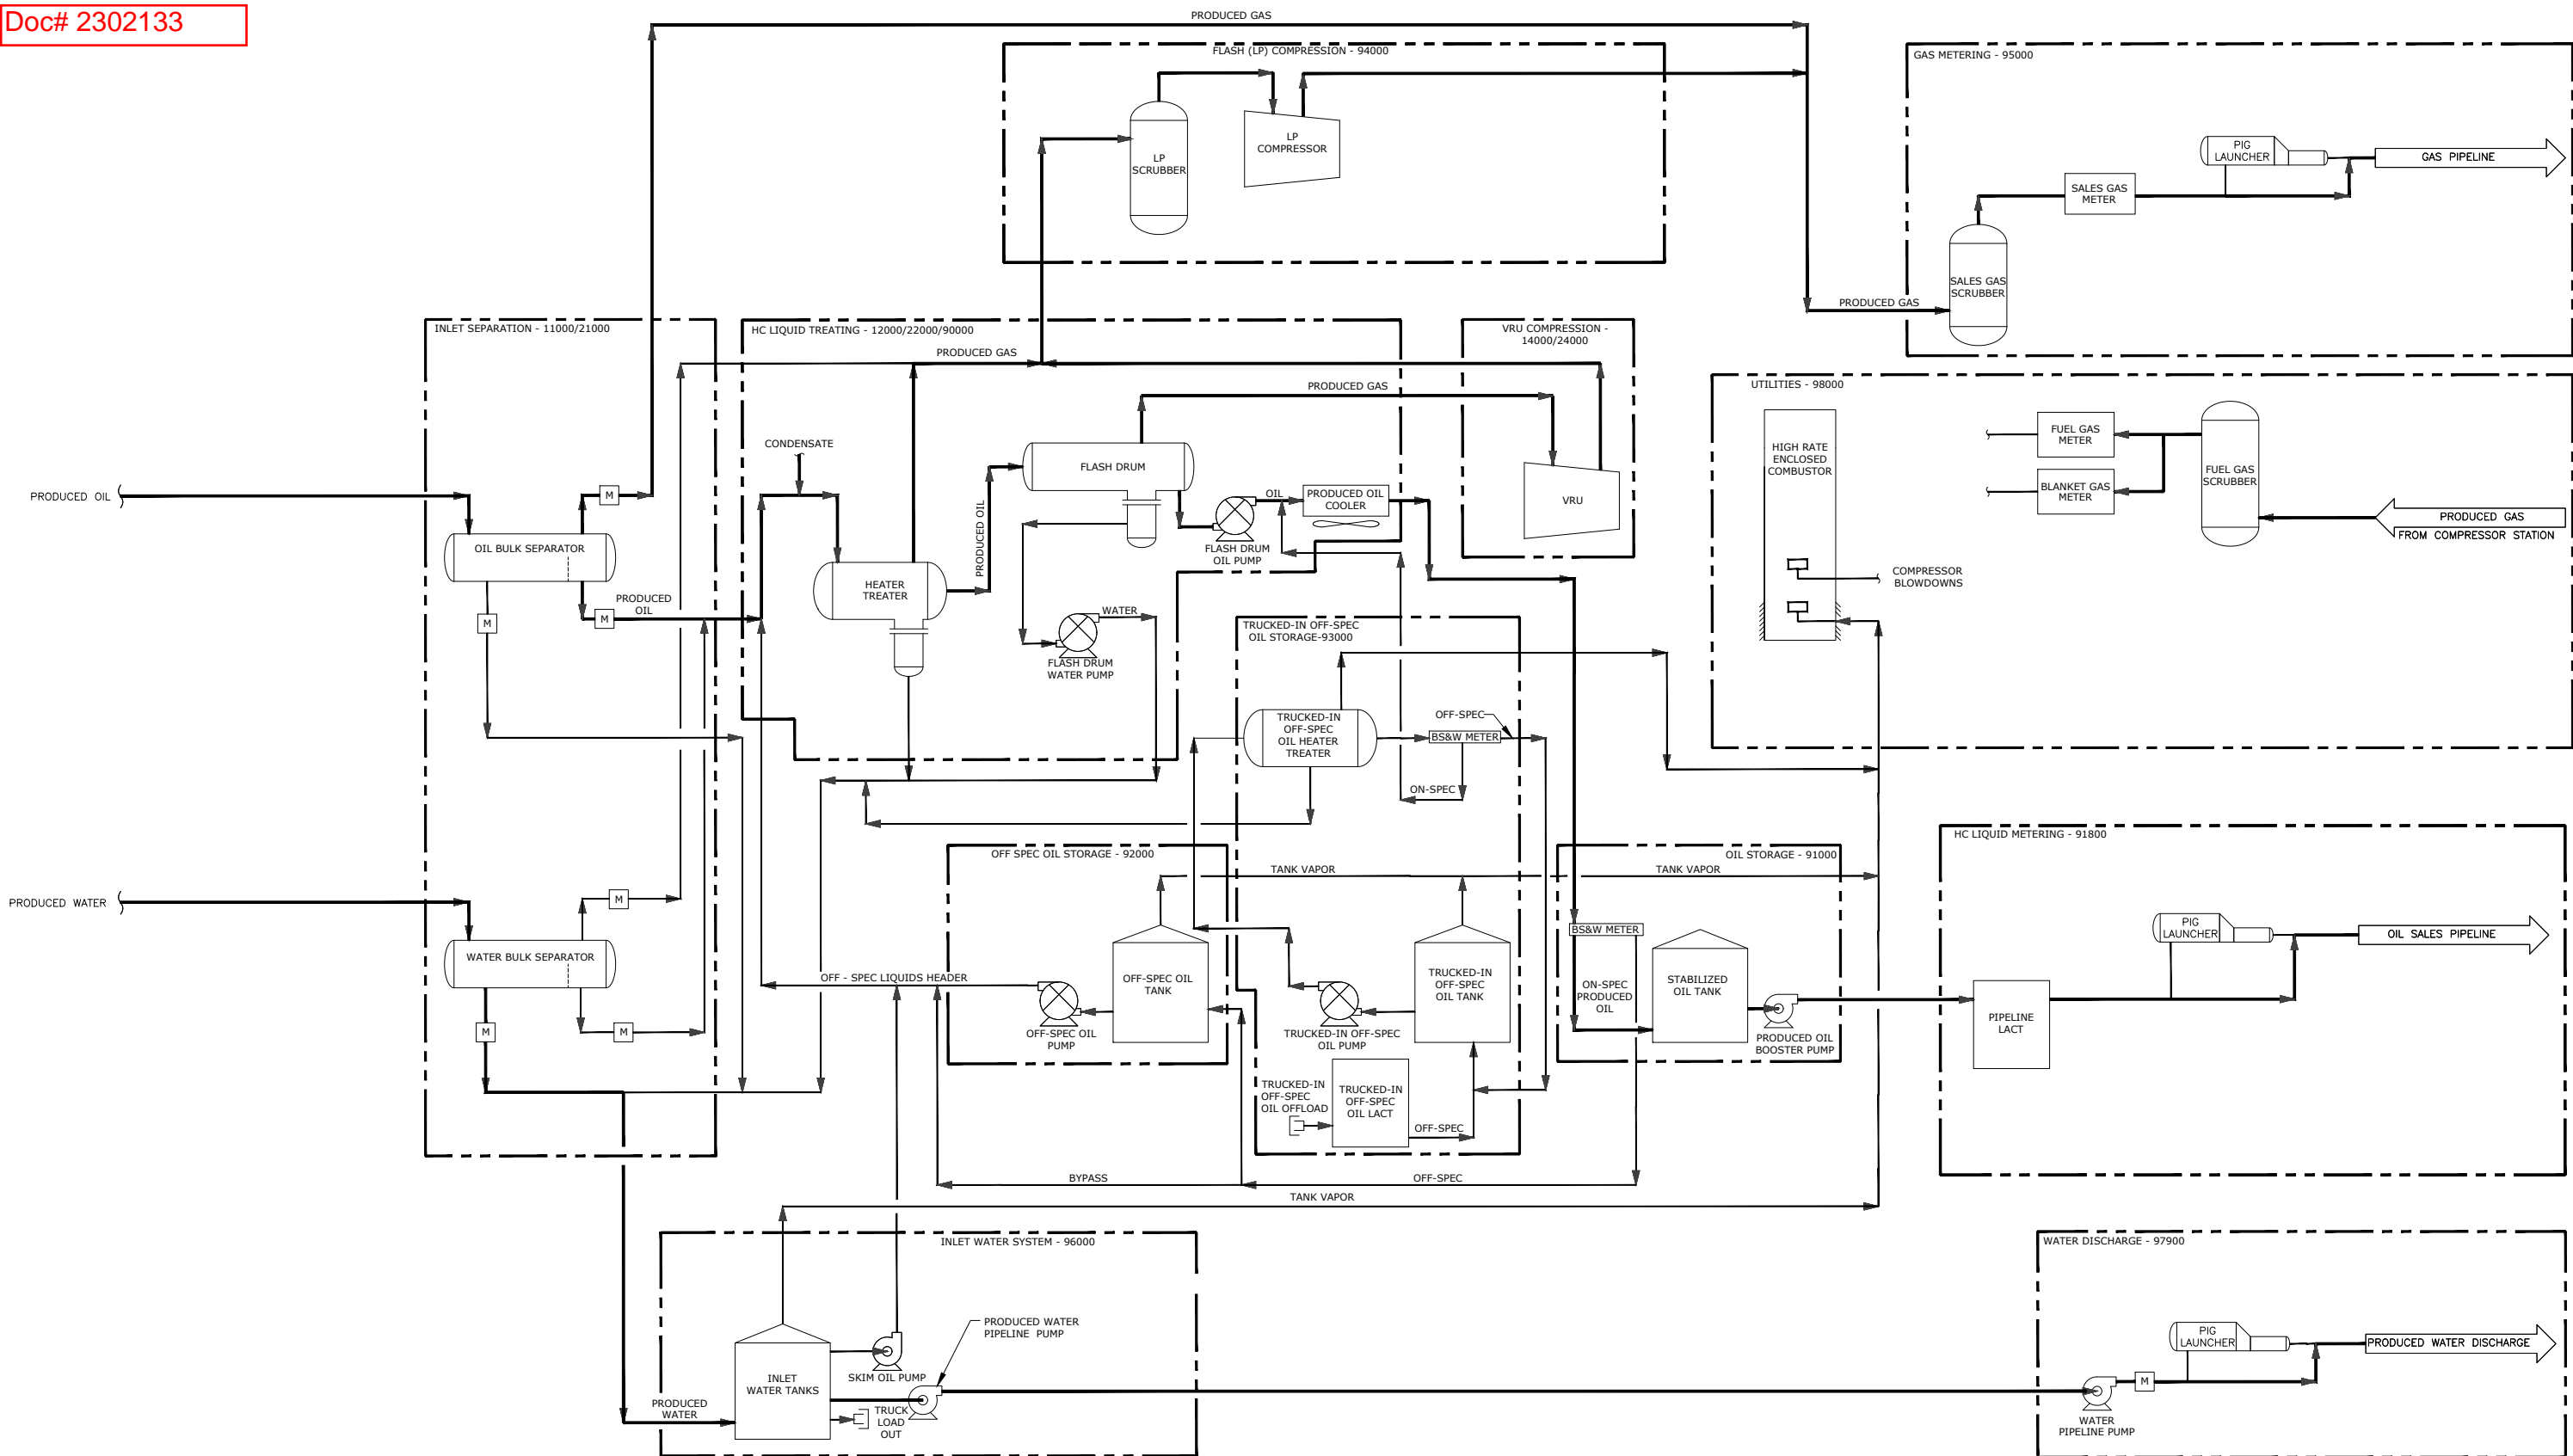

NOTES:

MEASUREMENT OF ALL STREAMS FOR ABOVE EQUIPMENT. M

REVISIONS							
A	ISSUED FOR DESIGN	MRA	04/09/18	EER	04/09/18	GAD	04/09/18
REV	DESCRIPTION	BY	DATE	CHK BY	CHK DATE	APR BY	APR DATE

APPROVALS		
	SIGNATURE	DATE
DRAWN		
CHECKED		
APPROVED		

Redi
**ENGINEERING
SERVICES, LLC**



BADGER CGF PROCESS FLOW DIAGRAM OVERVIEW

SCALE: NTS	DRAWING NO. BGR-WLD-011-00001	REV. A
---------------	----------------------------------	-----------