

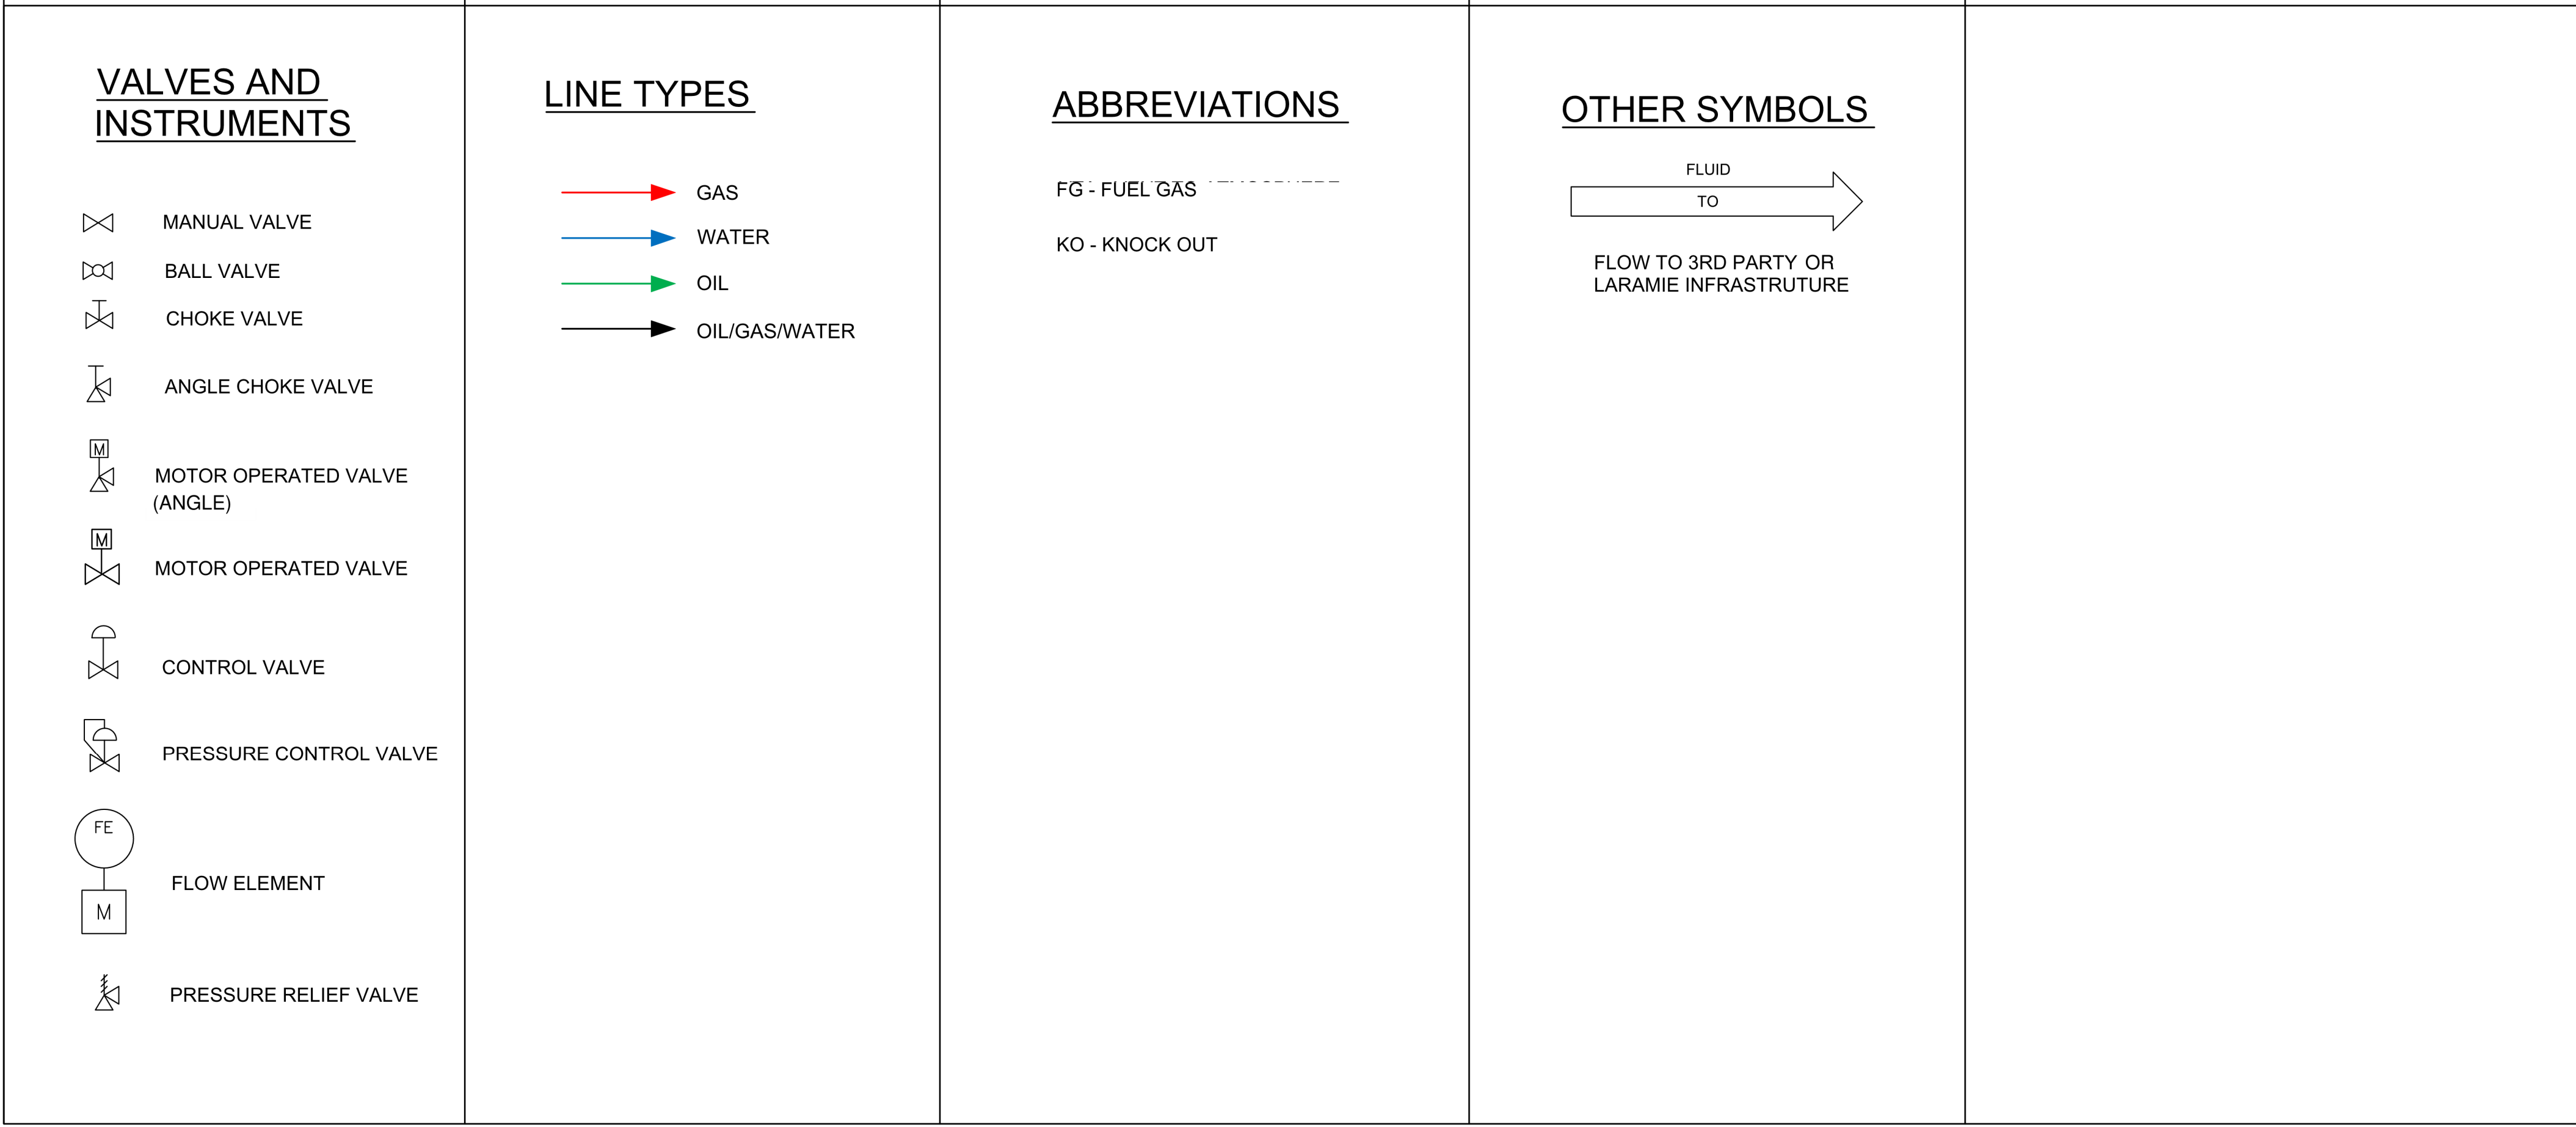


THIS DRAWING AND THE DESIGN IT COVERS ARE CONFIDENTIAL AND REMAIN THE PROPERTY OF MESA APPLIED TECHNOLOGIES, LLC. AND SHALL NOT BE DISCLOSED TO OTHERS OR REPRODUCED IN ANY MANNER OR USED FOR ANY PURPOSE WHATSOEVER EXCEPT BY WRITTEN PERMISSION BY THE OWNER.

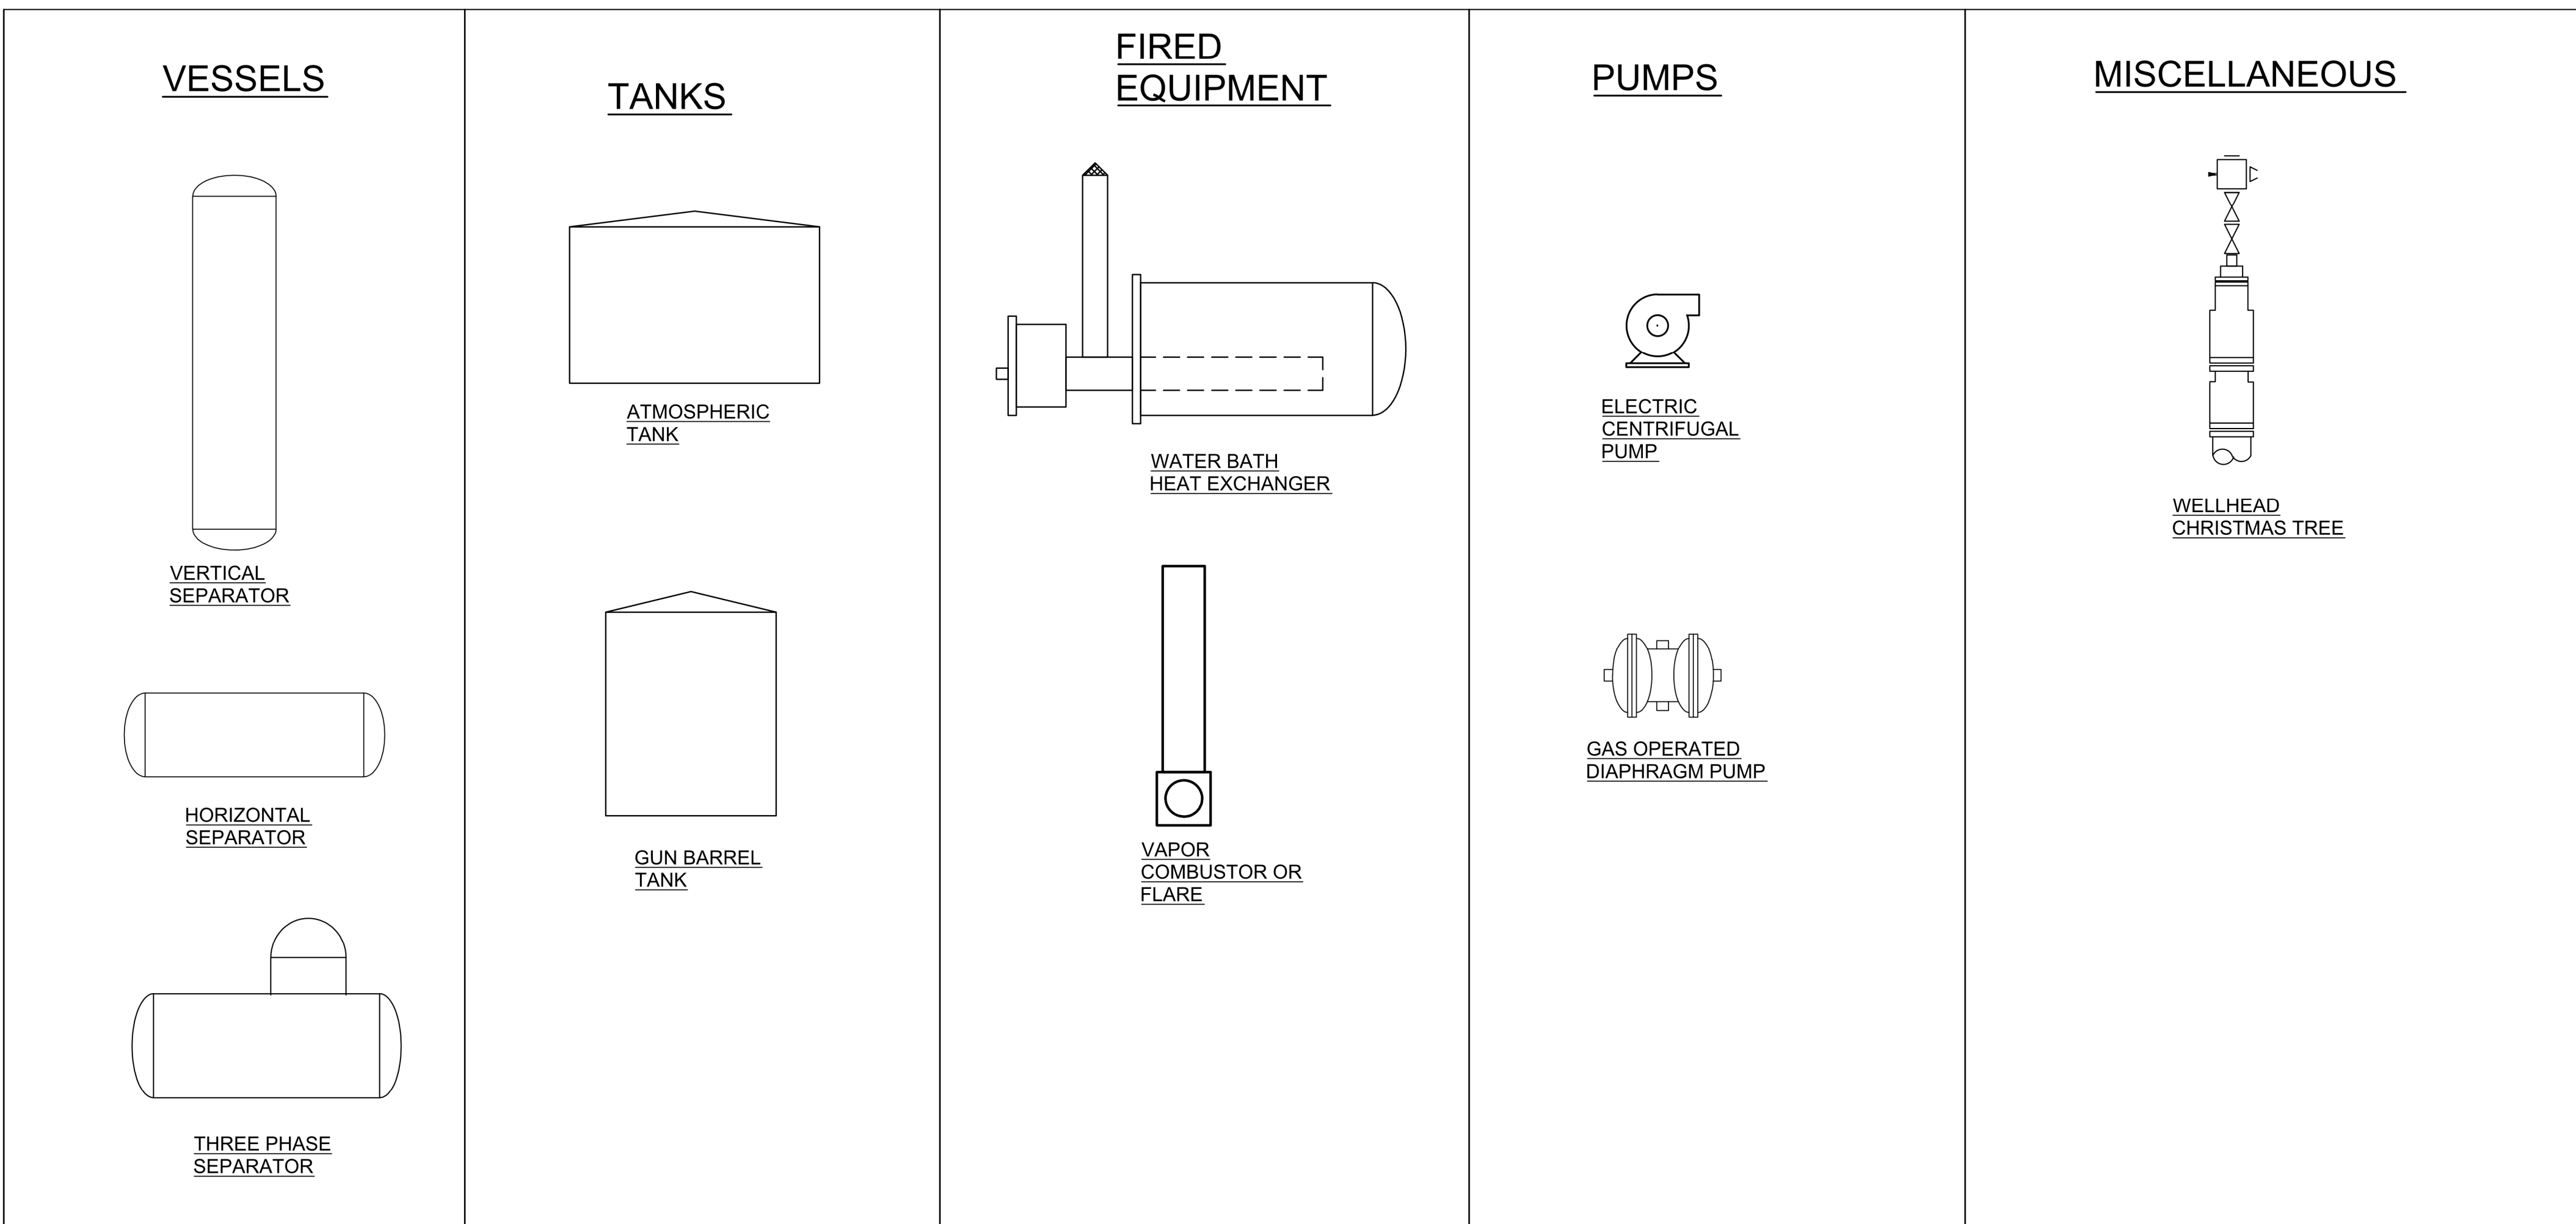

EQUIPMENT LIST				
MARK NUMBER	EQUIPMENT TYPE	VOLUME /CAPACITY	QUANTITY	TEMPORARY OR PERMANENT
1	RENTAL FLOWBACK SEPARATOR	AVAILABLE UNITS VARY	1 PER WELL	TEMPORARY
2	FLOWBACK TANK BATTERY	500 BBL PER TANK	VARIABLE	TEMPORARY
3	FLOWBACK PUMP	10,000 BBL/DAY	VARIABLE	TEMPORARY
4	KNOCKOUT VESSEL	AVAILABLE UNITS VARY	1 PER LOCATION	TEMPORARY
5	KNOCKOUT PUMP	AVAILABLE UNITS VARY	1 PER LOCATION	TEMPORARY
6	RENTAL COMBUSTOR	AVAILABLE UNITS VARY	VARIABLE	TEMPORARY
7	DIESEL GENERATOR	365 KW	2 PER LOCATION	TEMPORARY
8	HEAT EXCHANGER WITH BURNER	1000 MBTU/HR	5 PER LOCATION	PERMANENT
9	2-PHASE PROD SEPARATOR	3 MMSCFD	1 PER WELL	PERMANENT
10	GUN BARREL TANK	400 BBL	2 PER LOCATION	PERMANENT
11	WATER TANK	400 BBL	5 PER LOCATION	PERMANENT
12	OIL/CONDENSATE TANK	400 BBL	3 PER LOCATION	PERMANENT
13	KNOCKOUT VESSEL	1 BBL	1 PER LOCATION	PERMANENT
14	COMBUSTOR	109 MCFD	1 PER LOCATION	PERMANENT
15	WATER PUMP	50 GPM	2 PER LOCATION	TEMPORARY
16	KNOCKOUT PUMP	5 GPM	1 PER LOCATION	PERMANENT
17	TURBINE GENERATOR	48 KW	2 PER LOCATION	TEMPORARY
18	FUEL GAS SCRUBBER	1.8 MCFD	5 PER LOCATION	PERMANENT

NOTES:  
LOCATION: SWNE of Section 16, Township 9 South, Range 93 West, 6th P.M.

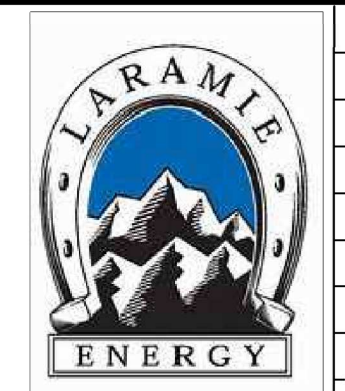

REVISIONS				
△				
△				
△				
△	ISSUED FOR INFORMATION	03/26/23	RZ	RZ GT
△	ISSUED FOR INFORMATION	03/13/23	RZ	RZ GT




**PROCESS FLOW DIAGRAM**  
LARAMIE ENERGY  
CURRIER BCU 0993-16-07  
LEGEND SHEET

DRAWN BY: RZ 09/30/21	REVIEWED BY: EM 09/30/21	SCALE: NOT TO SCALE
CHECKED BY: RZ 09/30/21	APPROVED BY: GT 09/30/21	DRAWING NUMBER LED-PFD-CURRIER 0993-16-07-0001

FILE LOCATION: C:\0365\MESA\CAD - FILES\LARAMIE ENERGY\PFD DEVELOPMENT\REV 0 DWG\LED-PFD-0001.DWG LAST SAVED: 09/29/21 BY: Estevan Minjarez PLOT TIME/DATE: September 29, 2021


THIS DRAWING AND THE DESIGN IT COVERS ARE CONFIDENTIAL AND REMAIN THE PROPERTY OF MESA APPLIED TECHNOLOGIES, LLC. AND SHALL NOT BE DISCLOSED TO OTHERS OR REPRODUCED IN ANY MANNER OR USED FOR ANY PURPOSE WHATSOEVER EXCEPT BY WRITTEN PERMISSION BY THE OWNER.

### FLOWBACK PROCESS FLOW DIAGRAM

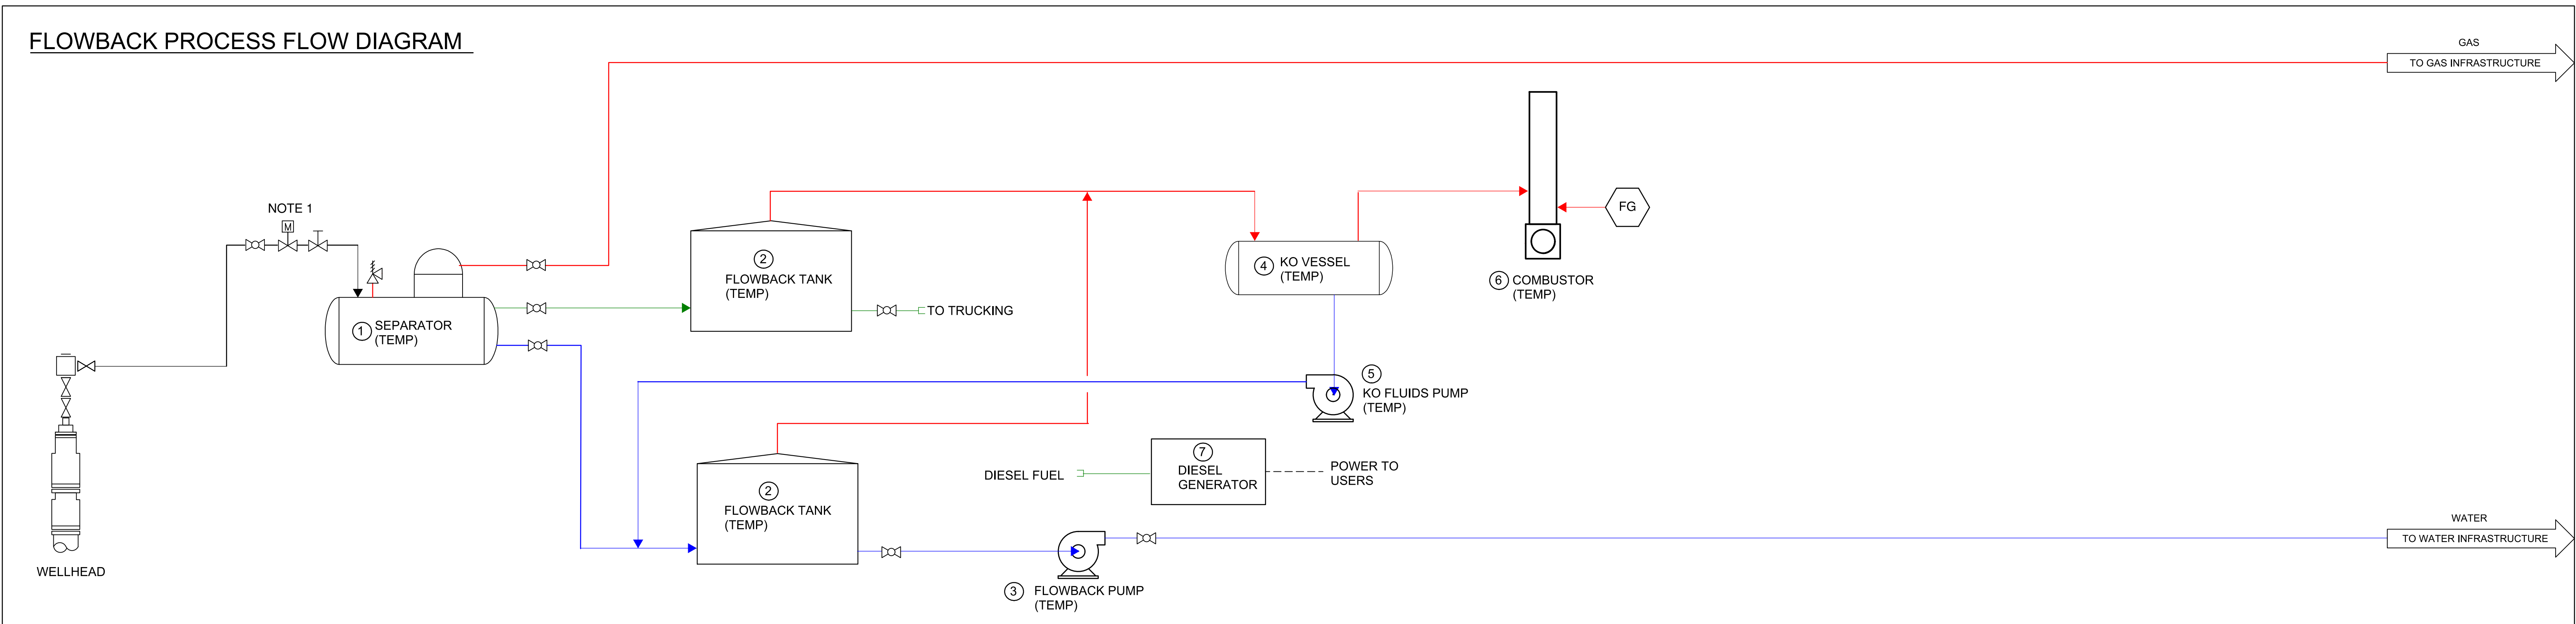


NOTE 2.

- NOTES:
1. THIS IS THE PRIMARY AUTOMATED SHUTDOWN/SHUTOFF VALVE FOR THE WELL.
  2. LOCATION: SWNE of Section 16, Township 9 South, Range 93 West, 6th P.M.

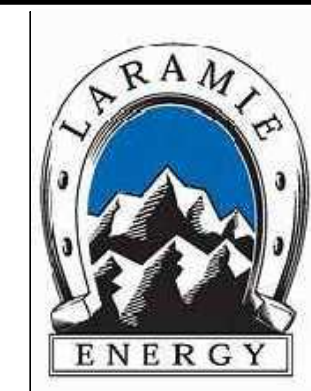

REVISIONS				
NO.	DESCRIPTION	DATE	BY	CHKD
△				
△				
△				
△	ISSUED FOR INFORMATION	03/26/23	RZ	RZ GT
△	ISSUED FOR INFORMATION	03/13/23	RZ	RZ GT

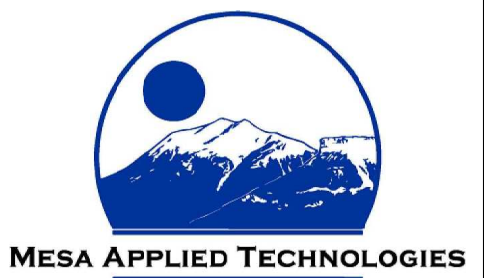

**PROCESS FLOW DIAGRAM**  
LARAMIE ENERGY  
CURRIER BCU 0993-16-07  
FLOWBACK PROCESS

DRAWN BY: RZ 09/30/21	REVIEWED BY: EM 09/30/21	SCALE: NOT TO SCALE
CHECKED BY: RZ 09/30/21	APPROVED BY: GT 09/30/21	DRAWING NUMBER: LED-PFD-CURRIER 0993-16-07-0002

FILE LOCATION: C:\0365\MESA\CAD - FILES\LARAMIE ENERGY\PFD DEVELOPMENT\FR REV 0 DWG'S\LED-PFD-0002.DWG LAST SAVED: 09/29/21 BY: Estevan Minjarez PLOT TIME/DATE: September 29, 2021

