





THIS DRAWING AND THE DESIGN IT COVERS ARE CONFIDENTIAL AND REMAIN THE PROPERTY OF MESA APPLIED TECHNOLOGIES, LLC. AND SHALL NOT BE DISCLOSED TO OTHERS OR REPRODUCED IN ANY MANNER OR USED FOR ANY PURPOSE WHATSOEVER EXCEPT BY THE OWNER.

FLOWBACK PROCESS FLOW DIAGRAM

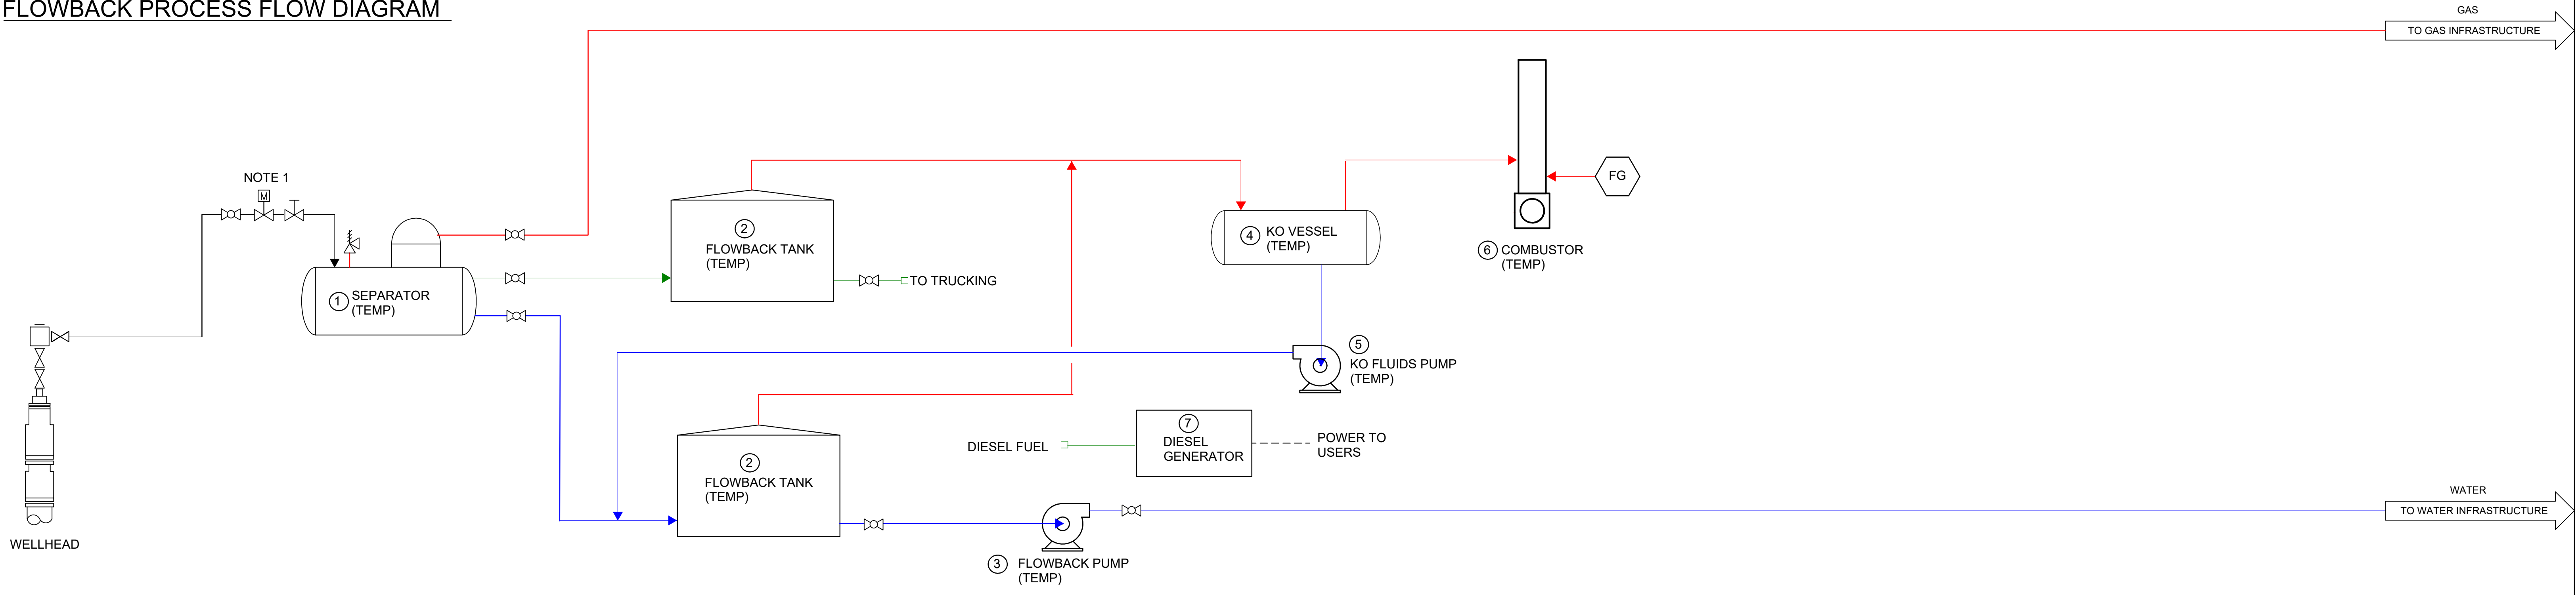

NOTE 2.

- NOTES:
- 1. THIS IS THE PRIMARY AUTOMATED SHUTDOWN/SHUTOFF VALVE FOR THE WELL.
  - 2. LOCATION: NENE Section 29, Township 9 South, Range 93 West, 6th P.M.

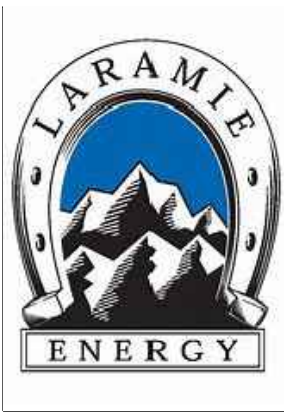


REVISIONS					
△					
△					
△					
△					
△					
△	ISSUED FOR INFORMATION	08/16/23	RZ	RZ	GT



PROCESS FLOW DIAGRAM  
LARAMIE ENERGY  
LARAMIE 0993-29-01  
FLOWBACK PROCESS


DRAWN BY: RZ	09/30/21	REVIEWED BY: EM	09/30/21	SCALE: NOT TO SCALE
CHECKED BY: RZ	09/30/21	APPROVED BY: GT	09/30/21	DRAWING NUMBER LED-PFD-LARAMIE 0993-29-01-0002

THIS DRAWING AND THE DESIGN IT COVERS ARE CONFIDENTIAL AND REMAIN THE PROPERTY OF MESA APPLIED TECHNOLOGIES, LLC. AND SHALL NOT BE DISCLOSED TO OTHERS OR REPRODUCED IN ANY MANNER OR USED FOR ANY PURPOSE WHATSOEVER EXCEPT BY WRITTEN PERMISSION BY THE OWNER.

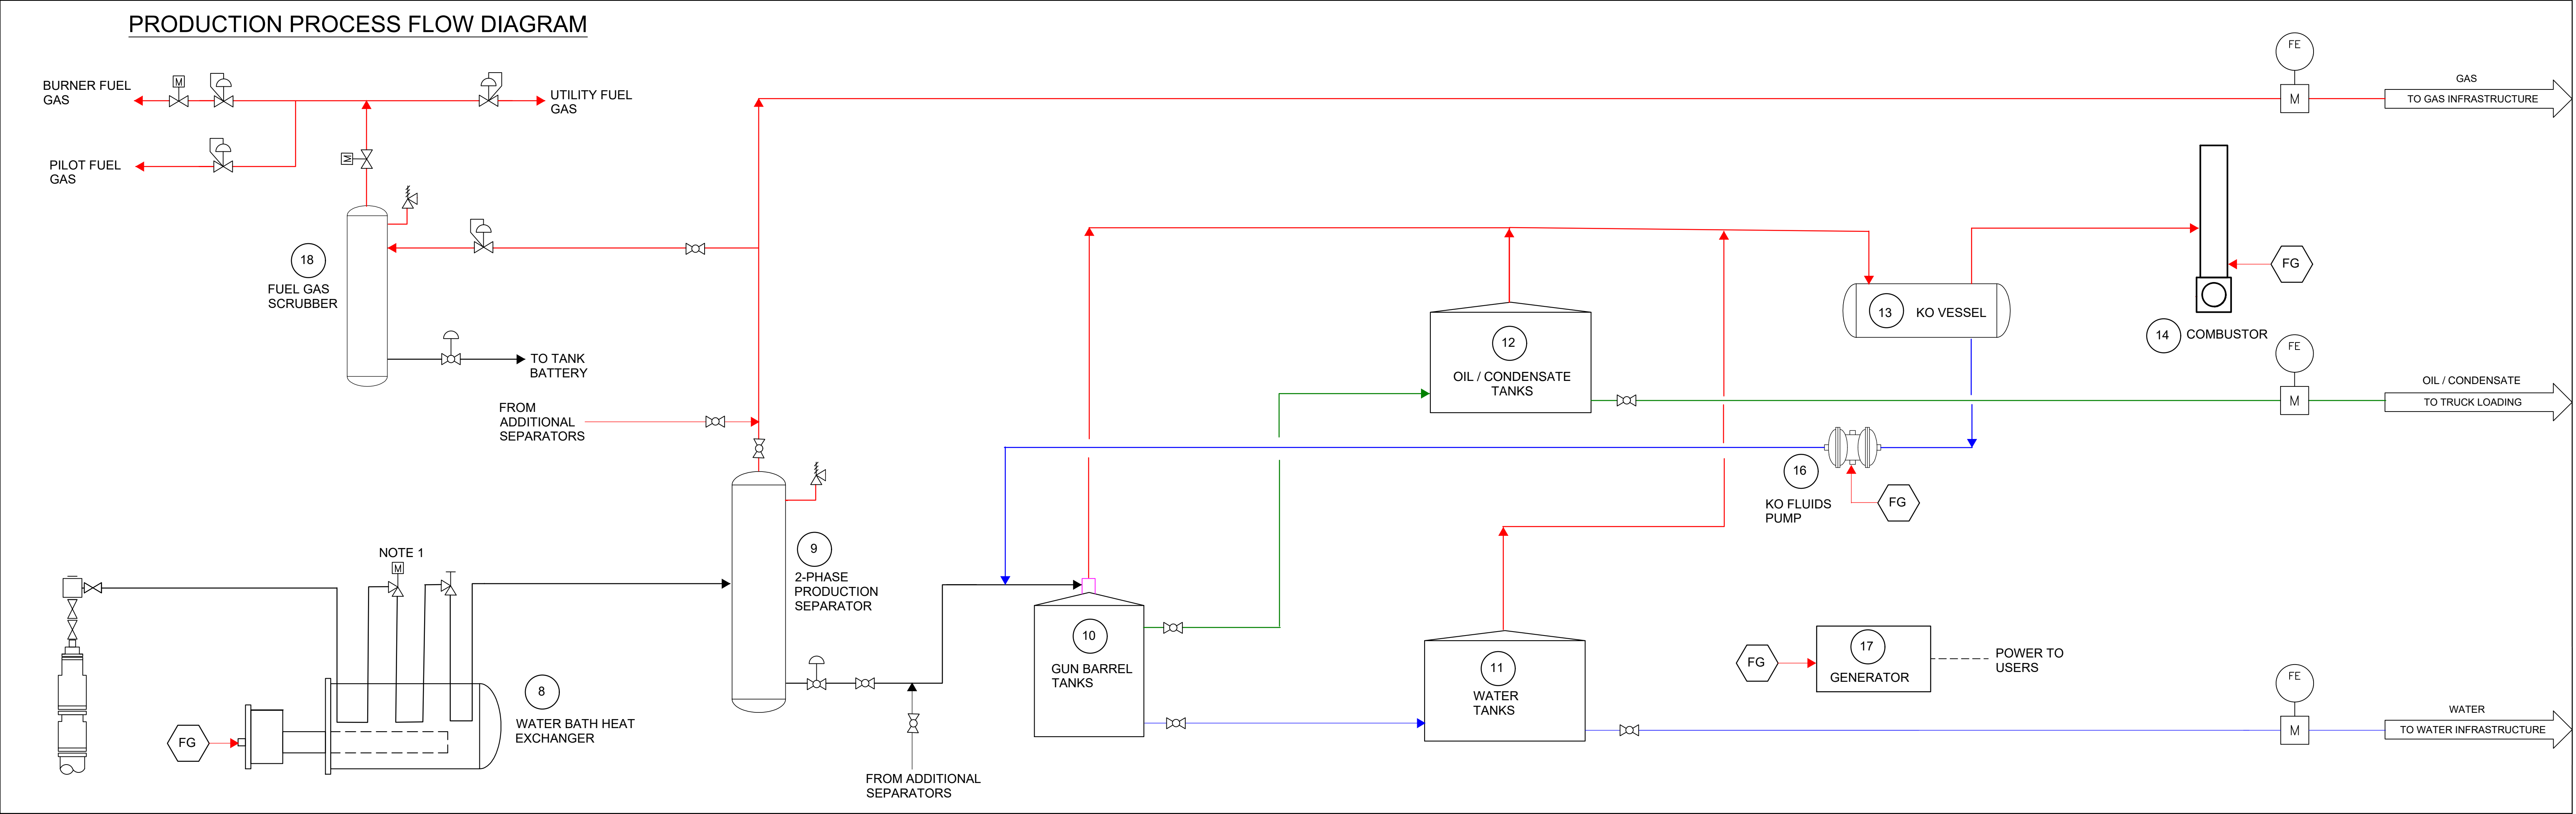

NOTE 2.

- NOTES:
1. THIS IS THE PRIMARY AUTOMATED SHUTDOWN/SHUTOFF VALVE FOR THE WELL.
  2. LOCATION: NENE Section 29, Township 9 South, Range 93 West, 6th P.M.

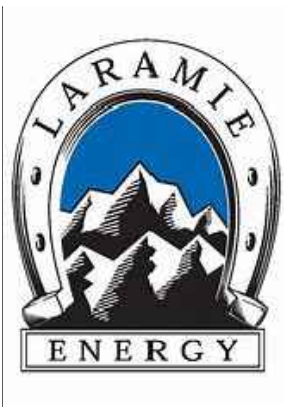

REVISIONS					
△					
△					
△					
△					
△					
△	ISSUED FOR INFORMATION	08/16/23	RZ	RZ	GT



**PROCESS FLOW DIAGRAM**  
LARAMIE ENERGY  
LARAMIE 0993-29-01  
PRODUCTION PROCESS

DRAWN BY: RZ	09/30/21	REVIEWED BY: EM	09/30/21	SCALE: NOT TO SCALE
CHECKED BY: RZ	09/30/21	APPROVED BY: GT	09/30/21	DRAWING NUMBER LED-PFD-LARAMIE 0993-29-01-0003