



 

 
 
 

 


 
 
 






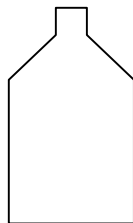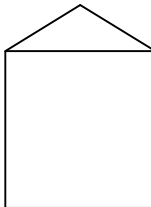

| VESELS | TANKS | MISCELLANEOUS | |
|--|--|--|--|
| <div><p>HORIZONTAL SEPARATOR</p><p>VERTICAL SEPARATOR</p></div> | <div><p>GUN BARREL</p><p>ATMOSPHERIC TANK</p></div> | <div><p>AIR COMPRESSOR</p><p>CENTRIFUGAL PUMP</p><p>COMBUSTOR</p><p>FIRED HEATER</p></div> | <div><p>GENERATOR</p><p>CHEMICAL PUMP</p><p>CHEMICAL TANK</p></div> |
| VALVES AND INSTRUMENTS | LINE TYPES | | |
| <div><p>PRESSURE RELIEF VALVE</p><p>PRESSURE/FLOW CONTROL VALVE</p><p>ACTUATED SHUTDOWN VALVE</p><p>CHECK VALVE</p><p>MANUAL BALL VALVE</p><p>FLOW ELEMENT</p></div> | <div><p>3-PH FLOW</p><p>GAS</p><p>WATER</p><p>CONDENSATE</p><p>VENT</p></div> | | |

| NR 334-1 Equipment List | | | | |
|--|-------------------------|------------------|------------------|------------------------|
| MARK NUMBER | EQUIPMENT TYPE | VOLUME/ CAPACITY | QUANTITY | TEMPORARY OR PERMANENT |
| 1 | GAS PROCESSING UNIT | | 1 - SINGLE GPU | PERMANENT |
| 2 | WELLHEAD 3-PH SEPARATOR | 4.8 MMSCFD | 1 PER WELL | PERMANENT |
| 3 | HEAT EXCHANGER | 0.5 MMBTU/HR | 1 PER SINGLE GPU | PERMANENT |
| 4 | PROD WATER TANK | 80 BBL | 1 PER PAD | PERMANENT |
| 5 | OIL TANK | 500 BBL | 7 PER PAD | PERMANENT |
| 6 | HEAT EXCHANGER | 0.5 MMBTU/HR | 1 PER TANK | PERMANENT |
| 7 | COMBUSTOR | 109 MSCFD | 3 PER PAD | PERMANENT |
| 8 | KNOCKOUT POT | 6.4 MMSCFD | 1 PER PAD | PERMANENT |
| 9 | AIR COMPRESOR | 2.12 CFM | 1 PER PAD | PERMANENT |
| NOTES: TANKS LOCATED IN 76'x38'x33" CONTAINMENT | | | | |

NR 334-1 Pad

Production Operations


Process Flow Diagram


DATE:3/11/2025

DRAWN BY:MDJ

SCALE:NOT TO SCALE

TEP Rocky Mountain, LLC



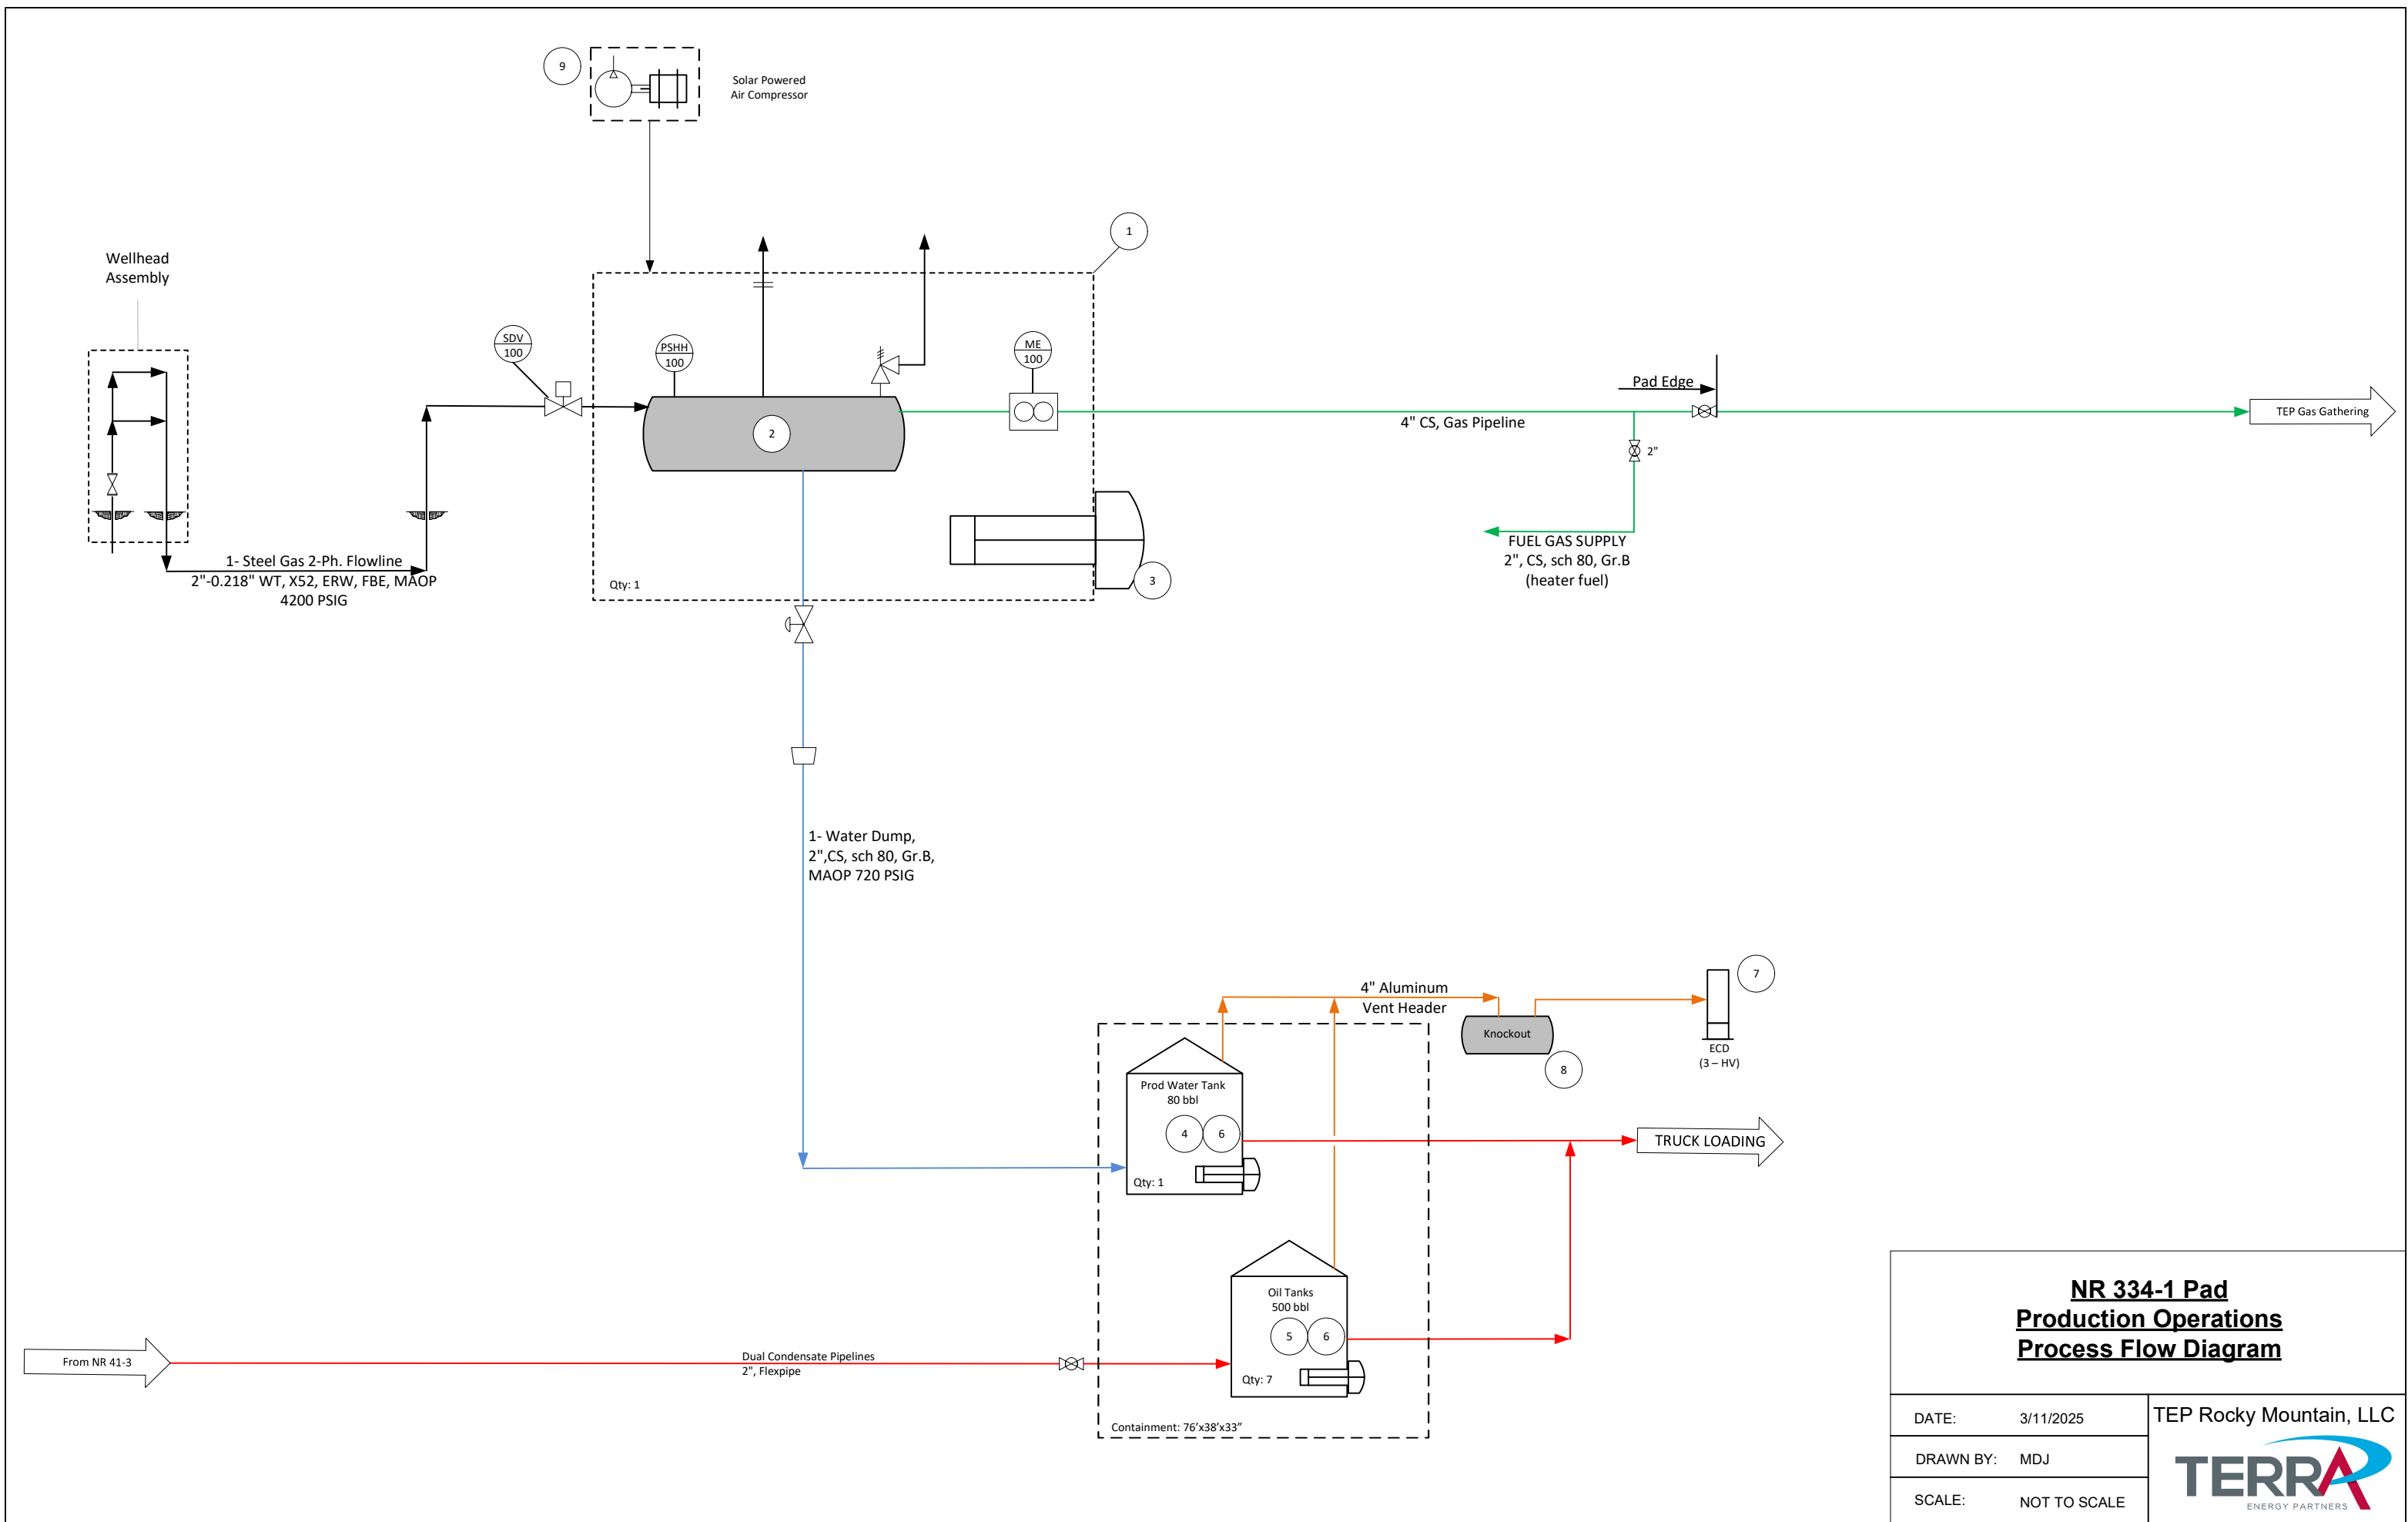

**NR 334-1 Pad
Production Operations
Process Flow Diagram**

| | | |
|-----------|--------------|-------------------------|
| DATE: | 3/11/2025 | TEP Rocky Mountain, LLC |
| DRAWN BY: | MDJ | |
| SCALE: | NOT TO SCALE | |

